



SECTION "A" BOILER ELEVATION
SCALE : 1/2" = 1' - 0"

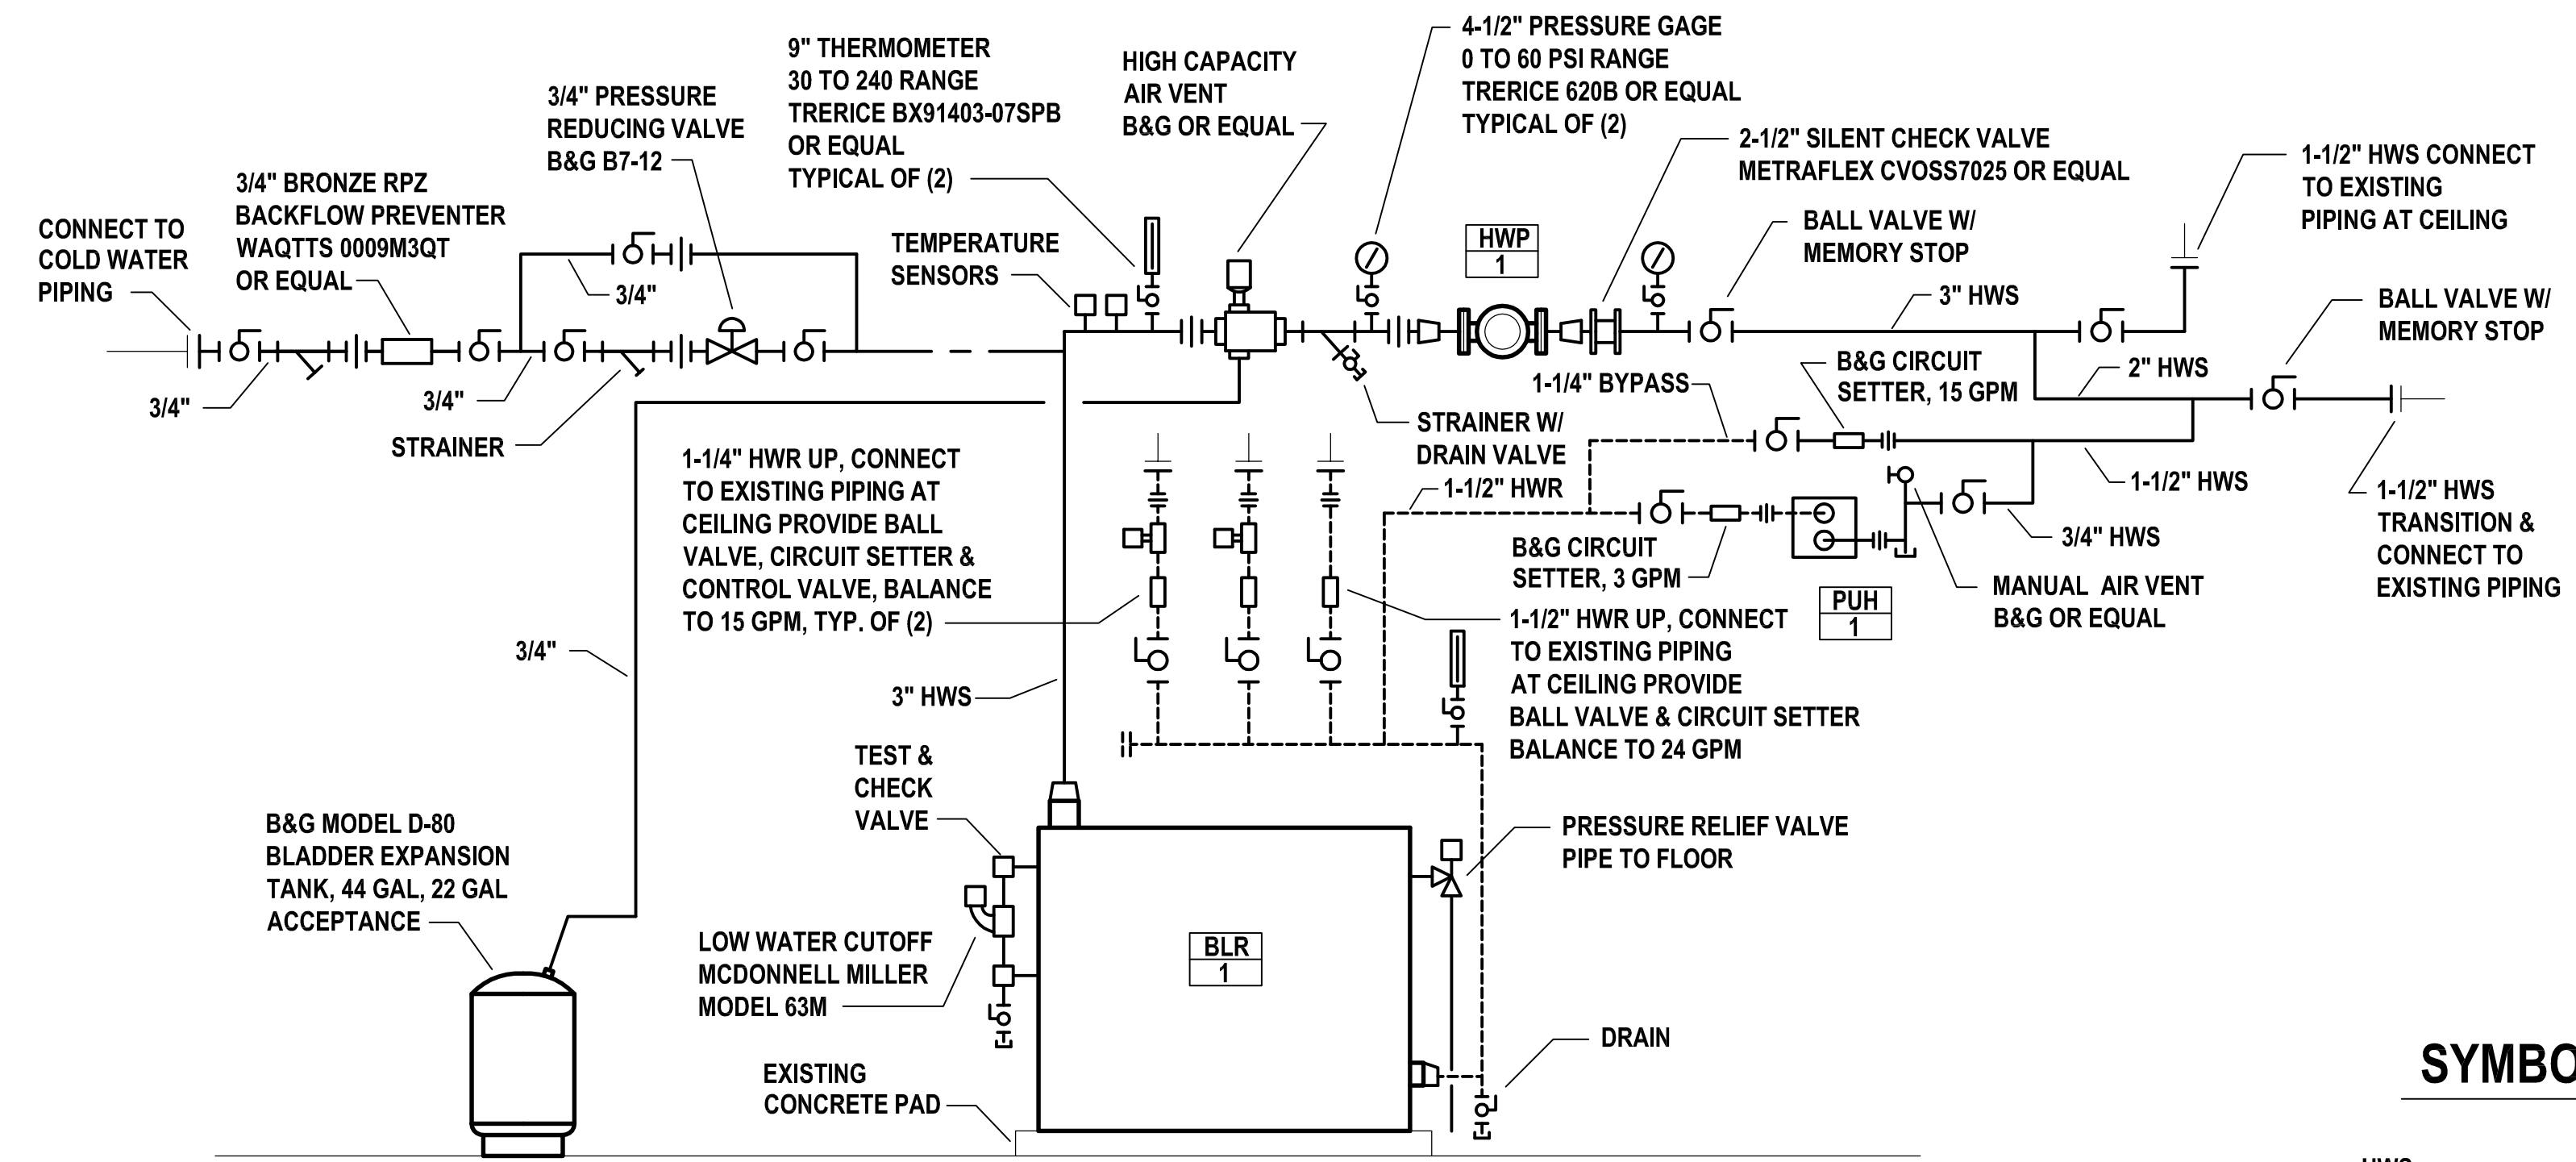


SCHEMATIC HOT WATER PIPING DIAGRAMS
NO SCALE

SYMBOLS LIST


- HWS — HOT WATER SUPPLY PIPING
- HWR --- HOT WATER RETURN PIPING
- CW --- DOMESTIC COLD WATER PIPING
- G — GAS PIPING
- V — VENT PIPING
- [Symbol] — BALL VALVE
- [Symbol] — STRAINER
- [Symbol] — UNION
- [Symbol] — PIPE TURNED UP
- [Symbol] — PIPE TURNED DOWN
- H.C. HEATING CONTRACTOR
- E.C. ELECTRICAL CONTRACTOR

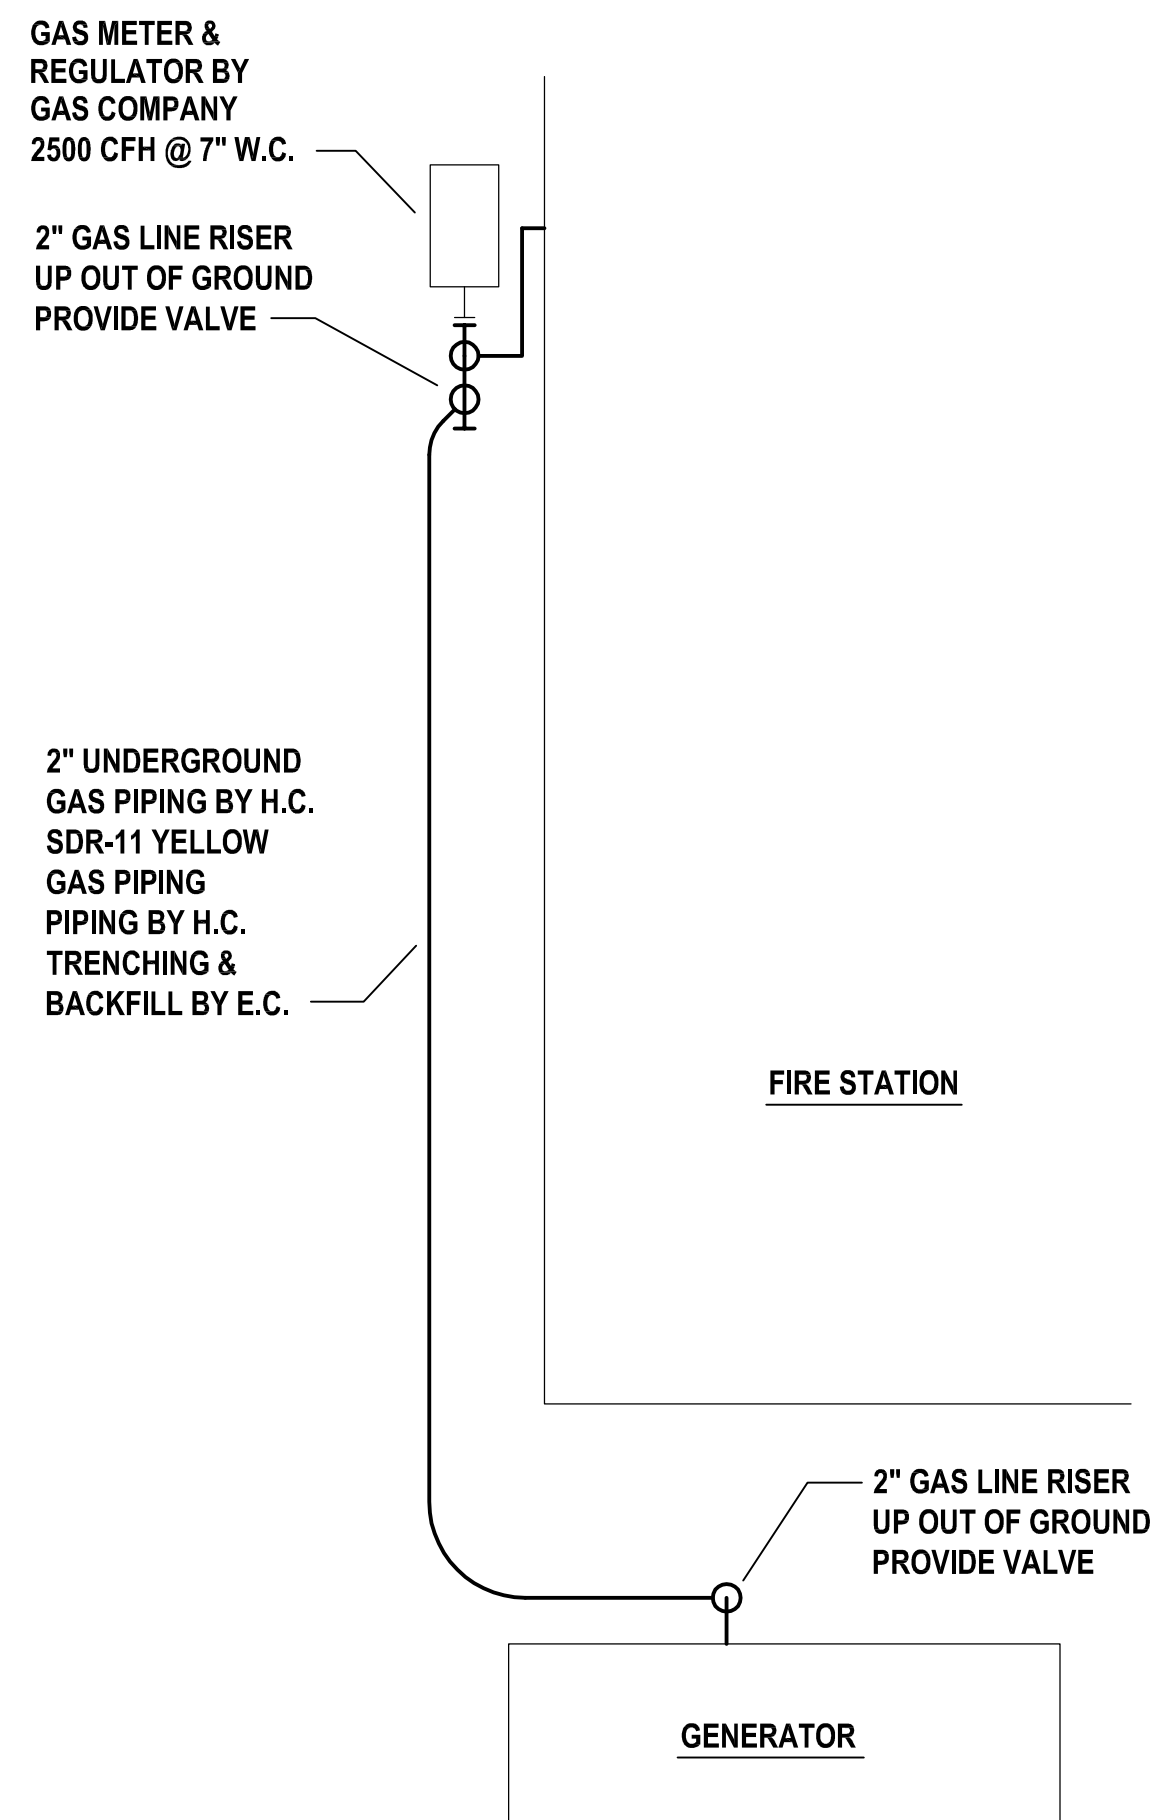

PARTIAL SITE PLAN
SCALE : 1/4" = 1' - 0"

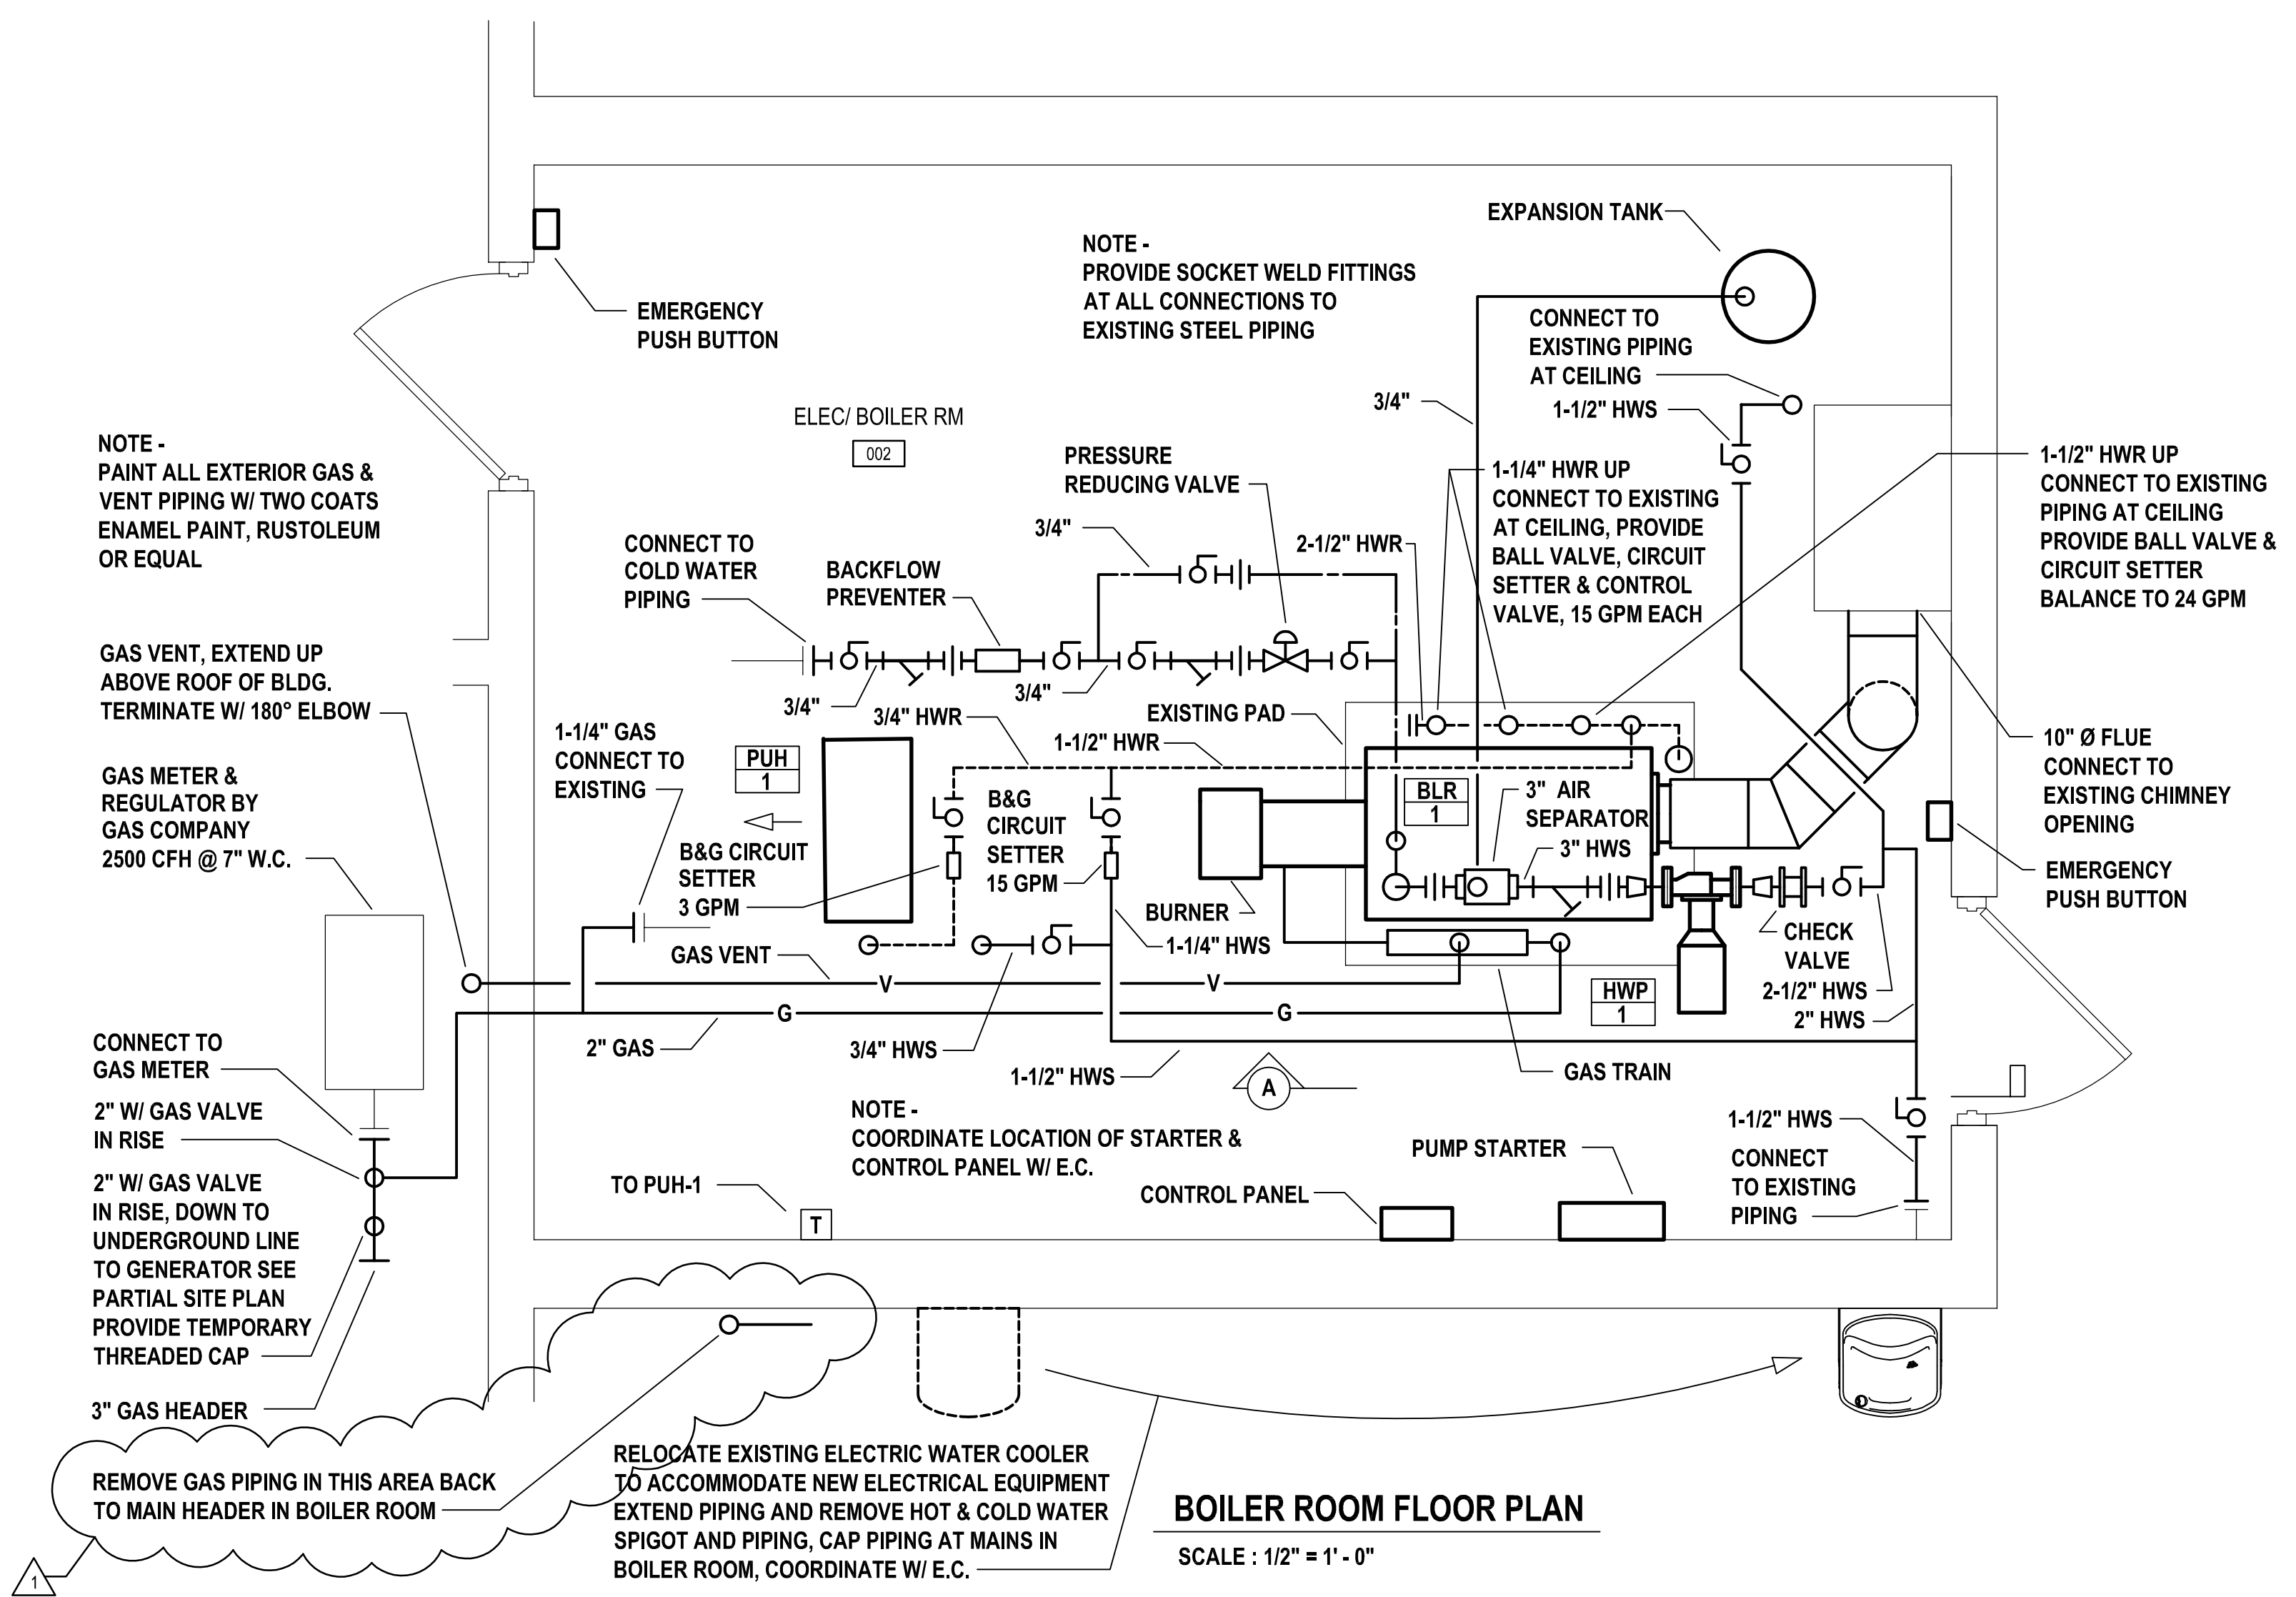

BOILER ROOM FLOOR PLAN
SCALE : 1/2" = 1' - 0"

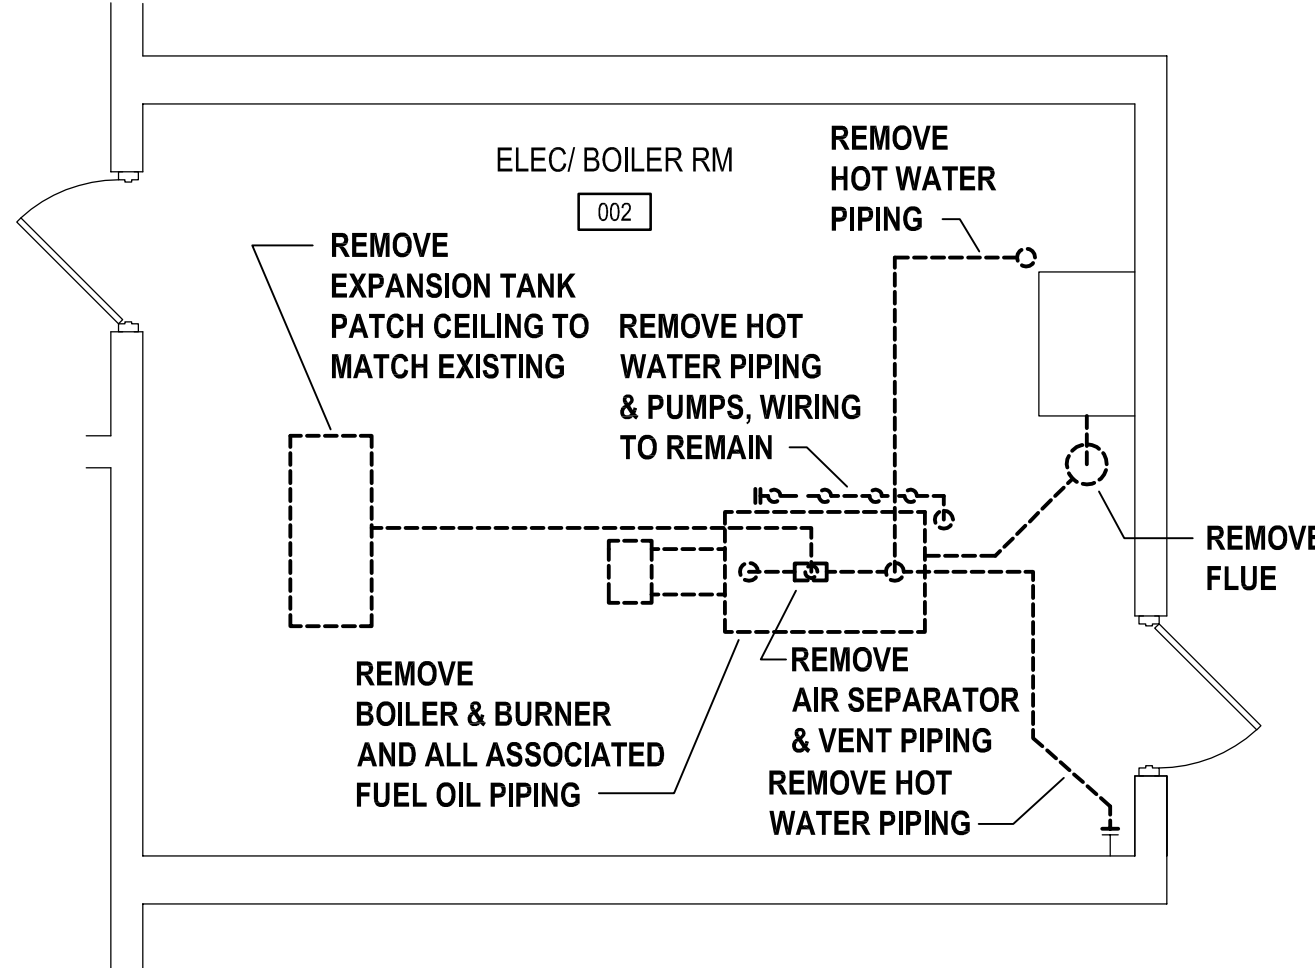

BOILER ROOM DEMOLITION PLAN
SCALE : 1/4" = 1' - 0"

REVISIONS	MARK	ISSUED DATE	DESCRIPTION	APPENDIX NO.1
1		06/12/20		

PROJECT NO: 81083-01
ISSUED DATE: 06/12/20
DRAWN BY: RCM
CHECKED BY: RCM
© BUCHART HORN, INC.

BOILER ROOM FLOOR PLAN