
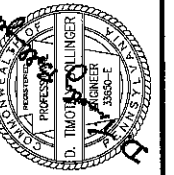


\\net.rk.com\va\Cloud\Projects\2015\18071\_6CPS\Cadd\Plans\Electrical\215-021-034-EP-PID-05.dwg Dec 19, 2019 12:33pm ENV:CTB Plot Scale 1=1 Plot Bk: abare Tab: Layout1

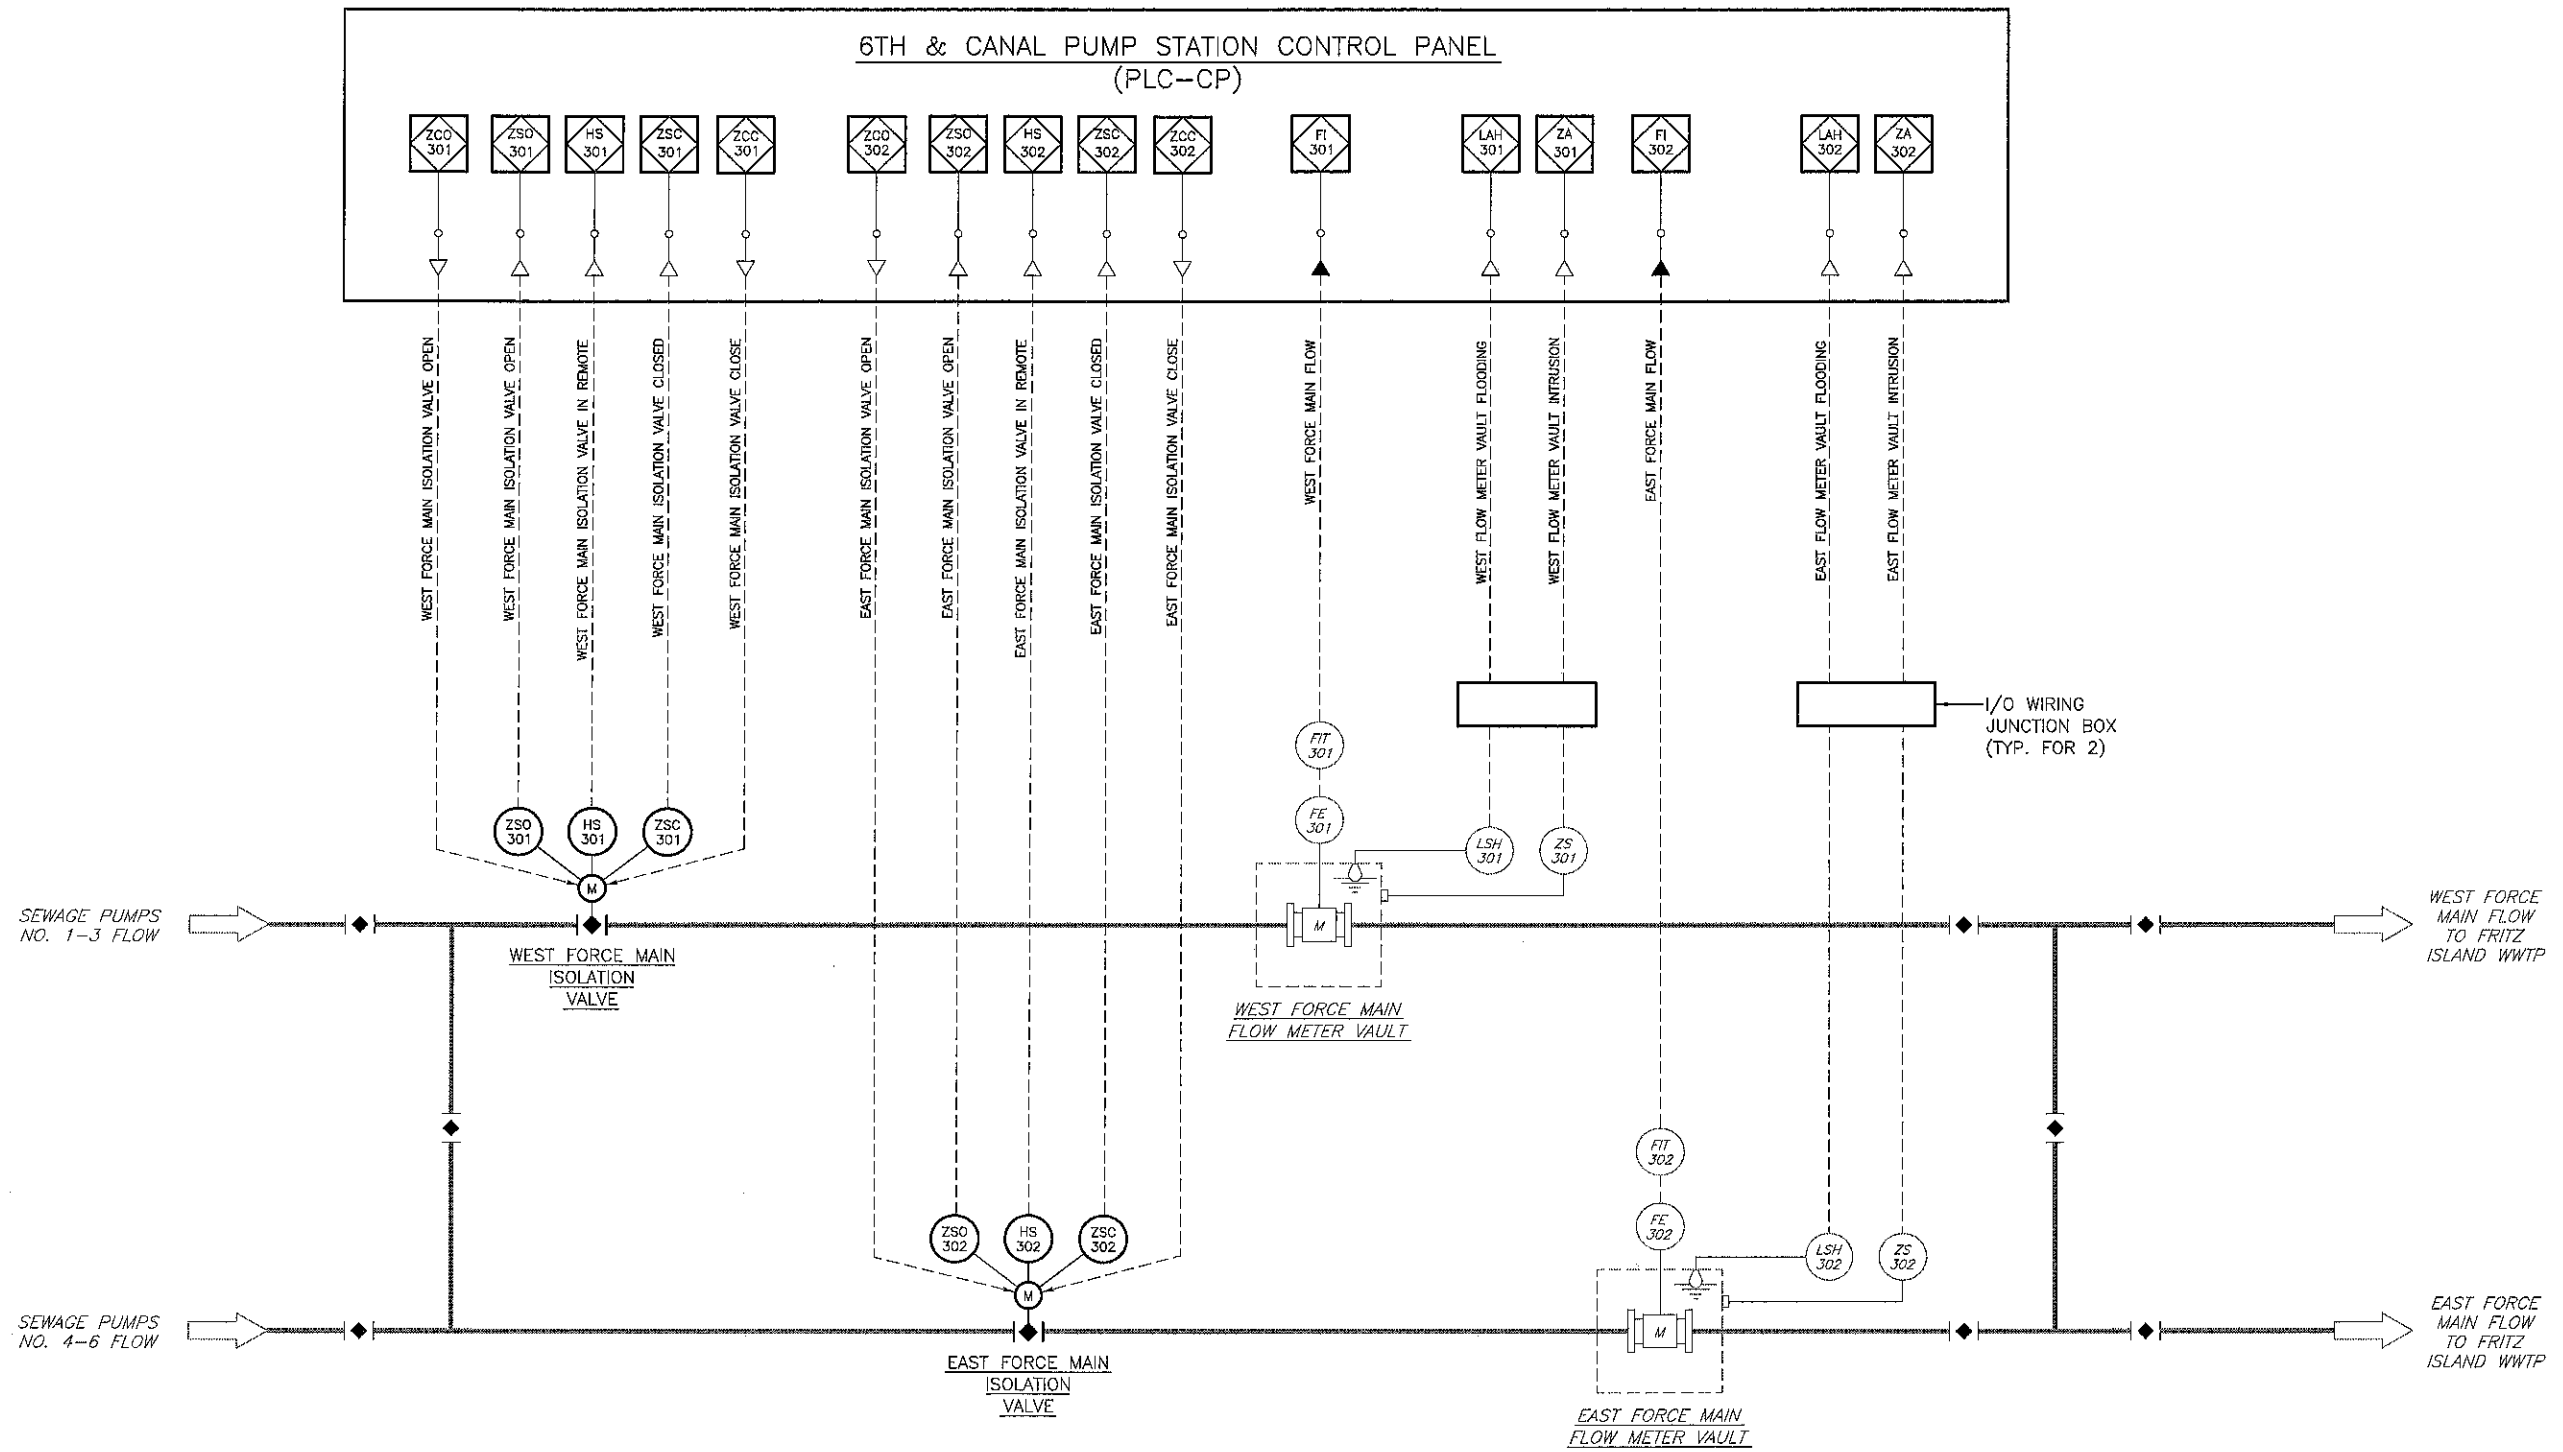

**RK&K**  
 3501 CONCORD ROAD  
 SUITE 100  
 YORK, PENNSYLVANIA 17402

NO.	DESCRIPTION	BY	DATE

CITY OF READING  
 SIXTH AND CANAL PUMP STATION  
 PHASE II UPGRADE PROJECT  
 PENNSYLVANIA  
 BERKS COUNTY  
 PUMP STATION FORCE MAINS P&ID

ENGINEER	DESIGNED BY
DTB	CMB
DRAWN BY	DATE
CMB	12/2019
PROJECT NUMBER	
2015-1	

DRAWING NUMBER  
**PID5**  
 SHEET NO. 04 OF 05