


1134 SCH. AVE ASSOC. LLC
 1134 SCH. AVE
 INST #S011023094
 19530739265363
 LOT 1 PBV 190 PG 11

NOTES:
 1. LIGHTING PREPARED BY:
 PENN LIGHTING ASSOCIATES
 PH (215) 735-5000
 www.pennlighting.com
 2. The exterior lighting shall comply with the provisions specified by the City of Reading and shall be reduced by 50% from 10:00PM till dawn

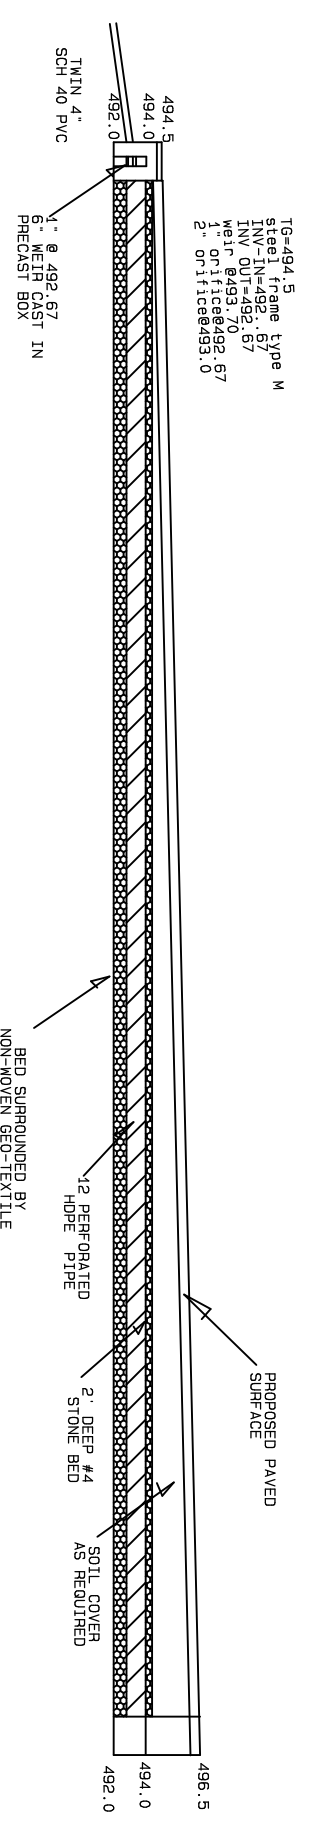

| | | | | | | |
|---|--|--|--------------------|--------------------------------------|------|---|
| STATUS: PRELIMINARY LAND DEVELOPMENT PLAN TITLE: DRAINAGE PLAN CLIENT: INGLESIA PENTECOSTAL MOVIMIENTO DE FE INC CITY OF READING, BERKS COUNTY, PENNSYLVANIA | CHECKED BY: DHL | DATE: 6/10/2021 | SCALE: 1" = 20' | REVISIONS NO. DATE BY DESCRIPTION | SEAL | PREPARED BY: TARSON LLC Corporate Office P.O. Box 160 Douglassville, PA 19518 PH 484 491 1329 |
| | PLAN NUMBER: 120-018-D SHEET NUMBER: 5 of 5 | © Copyright 2021, TARSON LLC. ALL RIGHTS RESERVED. The drawing of this work is the property of TARSON LLC. Reproduction or modification of this drawing, or any part thereof, is strictly prohibited except by written permission of this firm. All original and copies of plans, reports, surveys and technical data developed for this project by TARSON LLC or any of its subsidiaries shall be owned by and remain the property of TARSON LLC until final payment for all services rendered on the project are received and TARSON LLC provides written notice of the transfer of ownership. | | | | |